


J.L. Book
 105/57
 951/44
 1564/12
 9-17, 18

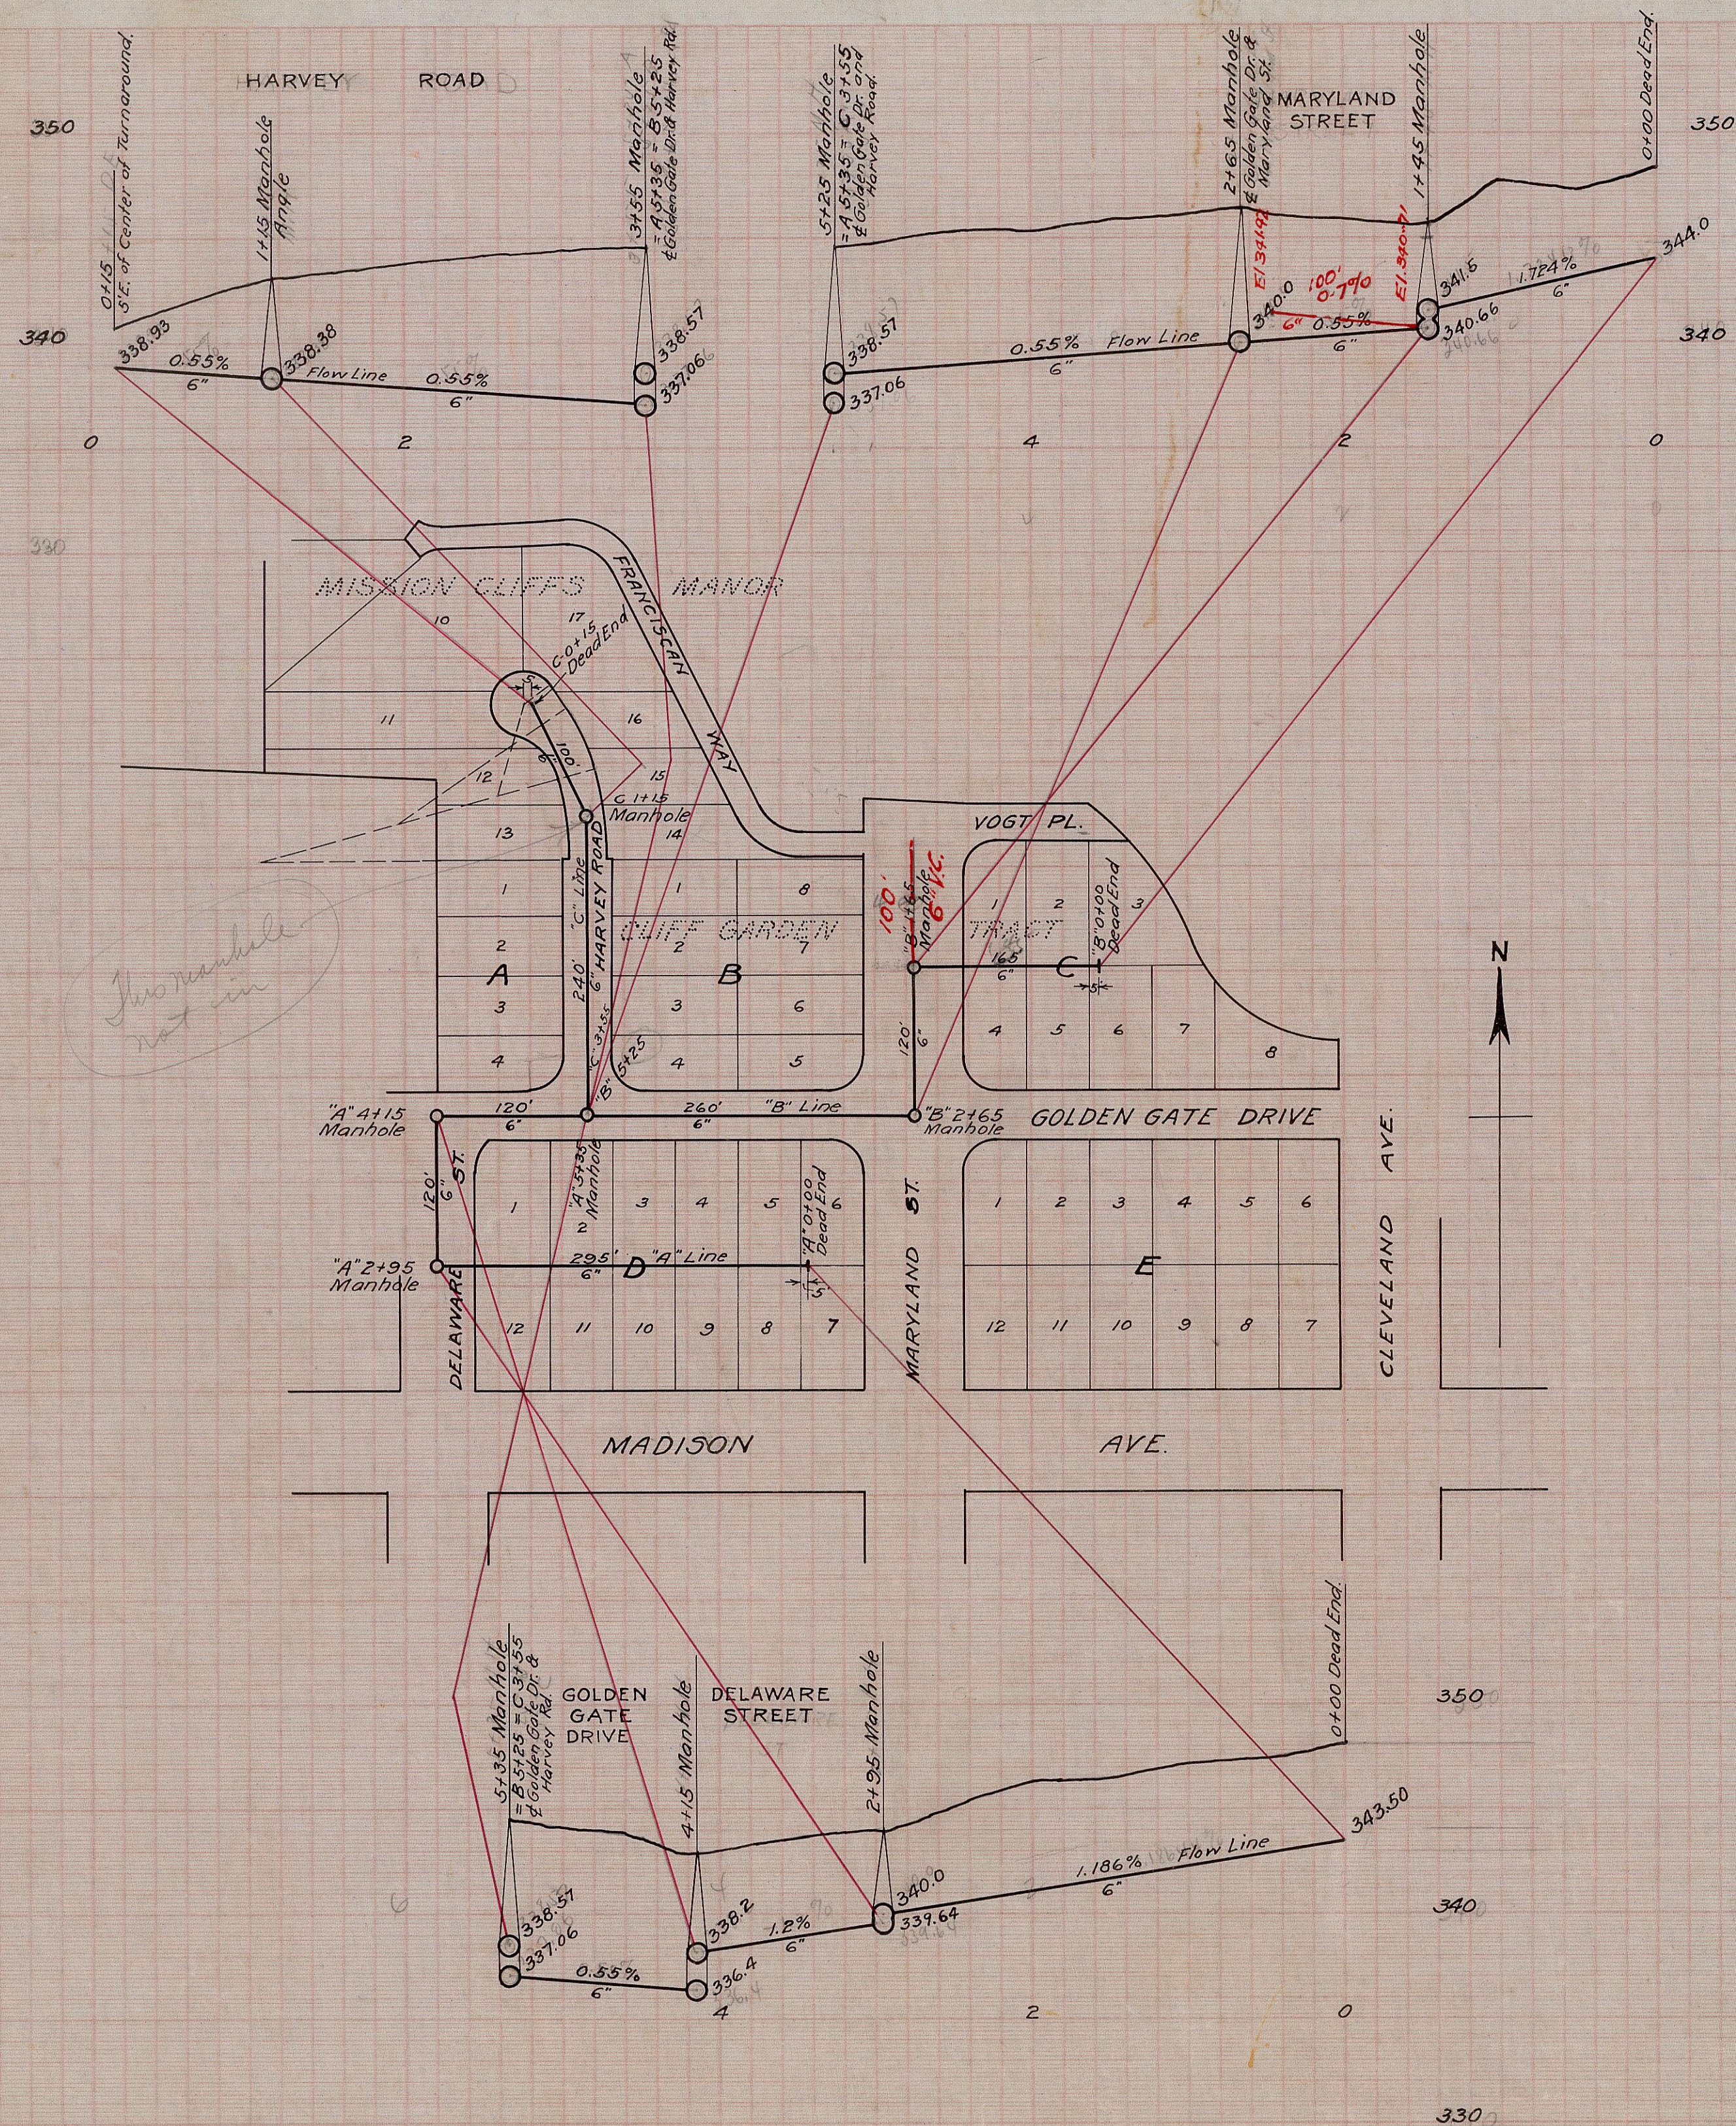

Note.
 Plan and Profiles plotted from Field Notes
 of D.A. Loeberstein. Copy of notes will be
 found in Field Book 360, pages 61 to 63.

CITY OF SAN DIEGO OPERATING DEPARTMENT	
CLIFF GARDEN TRACT Sanitary Sewers constructed under Private Contract.	
APPROVED CITY ENGINEER	DATE NOV. 24, 1926. SCALE (Vert. 1" = 6' PROFILE Horiz. 1" = 80' PLAN 1" = 100'
DRAWN BY G.R.H. TRACED BY G.R.H. CHECKED BY FIELD BOOKS	CHANGED DATE O.K. DRAWING NUMBER 433 D

SEP 2 - 1963